


ground floor electrical plan
scale 1:100

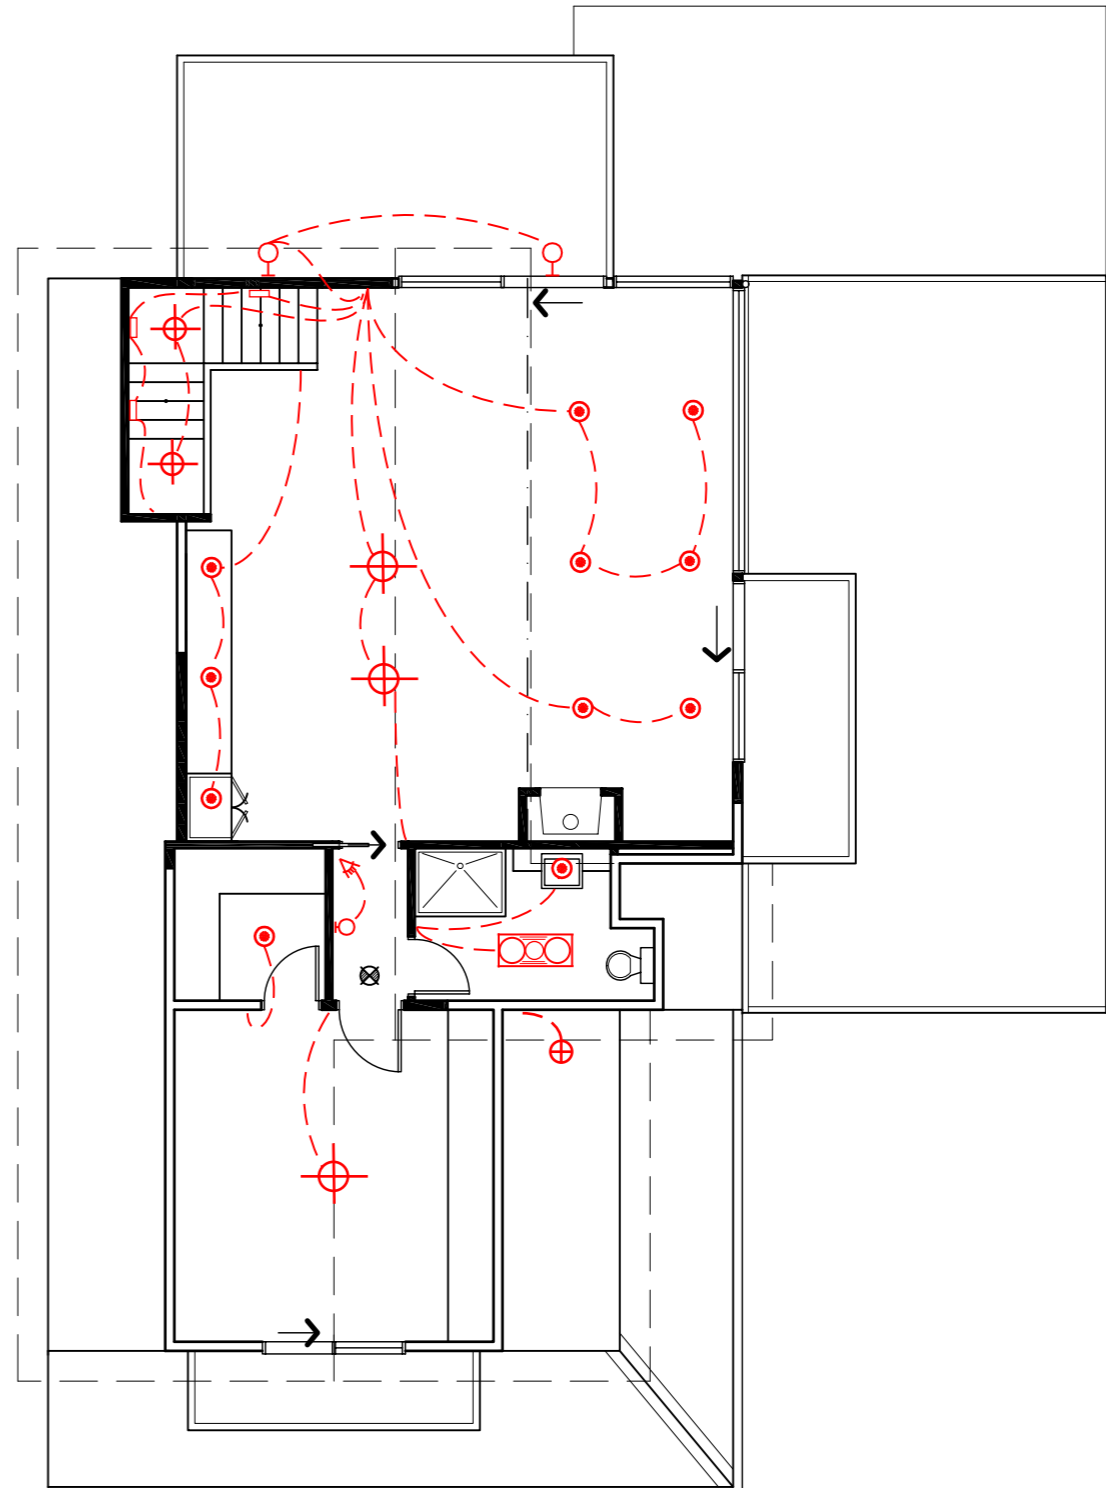

upper floor electrical plan
scale 1:100